


1 TYPICAL PANEL OPTIONS

SCALE: 3/4" = 1'-0"

CHAMFER

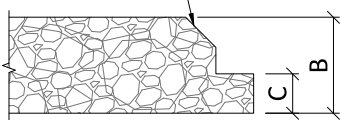


TEGULAR

PANEL OPTIONS	
B	C
1"	7/16"
1-3/8"	13/16"
2"	1-7/16"

FINISH OPTIONS
PRIMED CLEAR
PRIMED WHITE
CUSTOM PAINTED

2 PANEL PROFILE OPTION - TEGULAR

 SCALE: 6" = 1'-0"



SQUARE

PANEL OPTIONS
5/8"
1"
1-3/8"
2"

FINISH OPTIONS
PRIMED CLEAR
PRIMED WHITE
CUSTOM PAINTED

3 PANEL PROFILE OPTION - SQUARE

SCALE: 6" = 1'-0"

STRANDTEC- LAY-IN CEILING
PANEL OPTIONS

SHEET NUMBER


1

SCALE: AS NOTED

LAST REVISED: 7/6/2022


DRAWN BY: BH

DO NOT SCALE DRAWING. FIGURED DIMENSIONS ARE TO BE FOLLOWED. READ THIS DRAWING IN CONNECTION WITH GENERAL ARCHITECTURAL PLANS, STRUCTURAL PLANS, AND OTHER RELATED DRAWINGS. THESE DRAWINGS REPRESENT ASI'S UNDERSTANDING AND INTERPRETATION OF THE ARCHITECTURAL DRAWINGS AND HOW ASI PRODUCTS RELATE TO THE PROJECT. COPYRIGHT ASI © 2022

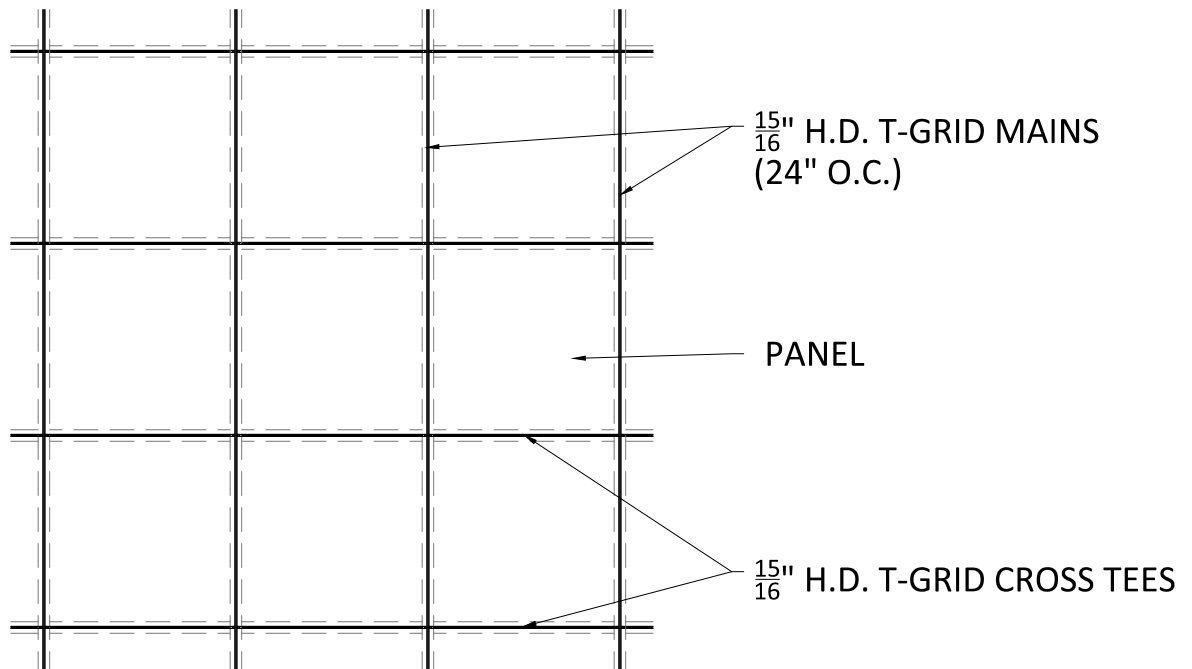

1 TYPICAL LAY-IN CEILING PANEL T-GRID LAYOUT
2 SCALE: 1/2" = 1'-0"

	PANEL SIZE	
NOMINAL	2X2	2X4
ACTUAL SIZE	23.75" X 23.75"	23.75" X 47.75"
RECOMMENDED CROSS TEE/FURRING SPACING	24" O.C.	48" O.C.

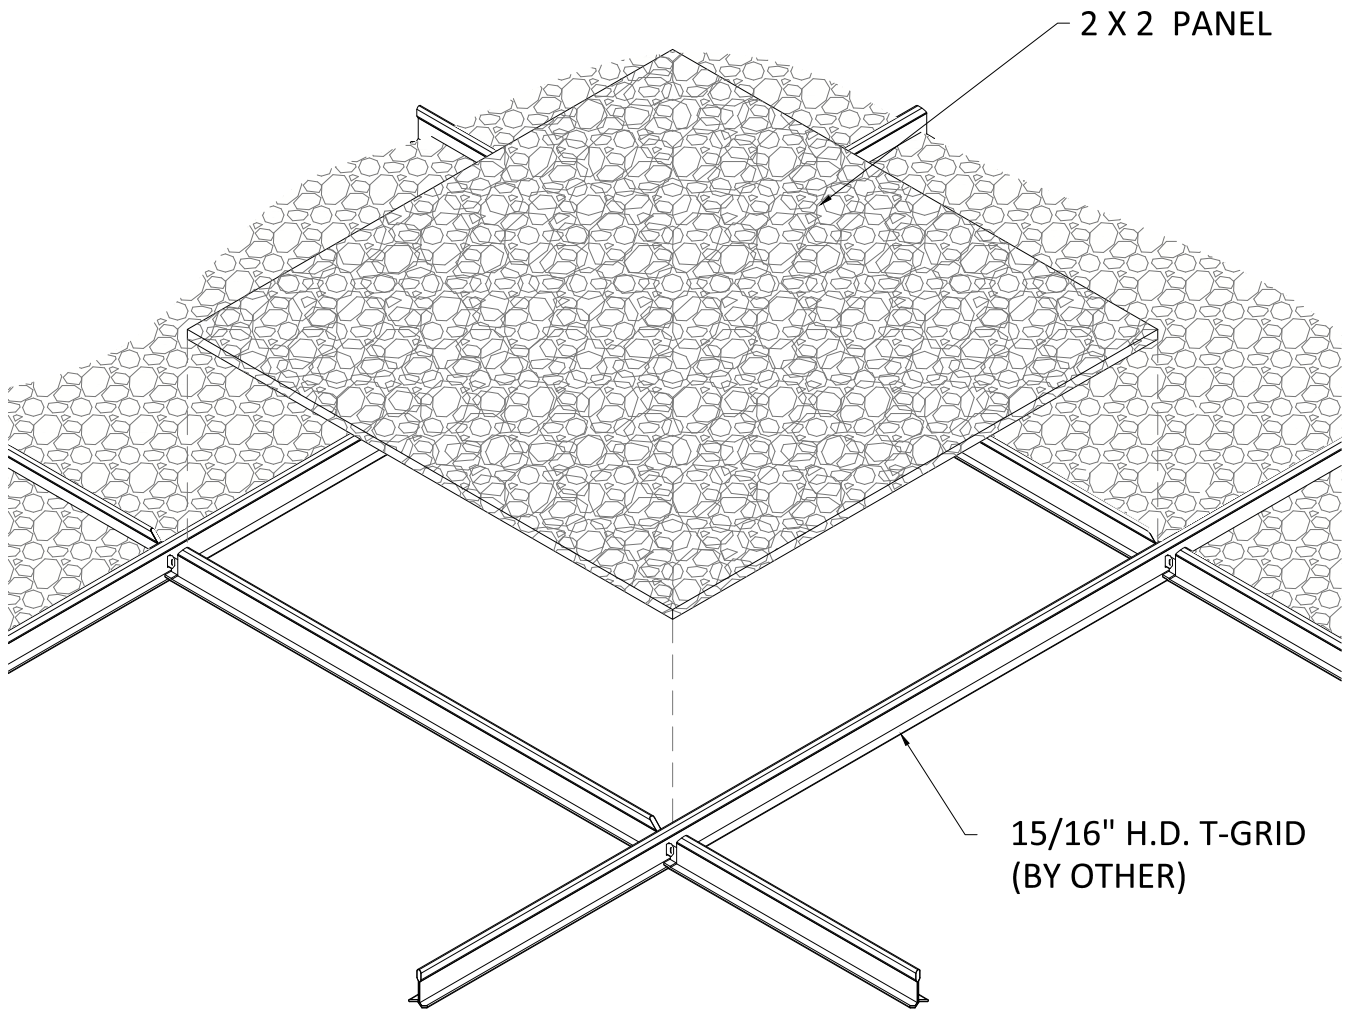

1
3 LAY-IN CEILING ISOMETRIC
SCALE: 1 1/2" = 1'-0"

ASi

123 Columbia Court North, Chaska,
Minnesota 55318 P. 800.527.6253

STRANDTEC- LAY-IN CEILING ISOMETRIC

SCALE: AS NOTED

LAST REVISED: 7/6/2022

DRAWN BY: BH


SHEET NUMBER

3

DO NOT SCALE DRAWING. FIGURED DIMENSIONS ARE TO BE FOLLOWED. READ THIS DRAWING IN CONNECTION WITH GENERAL ARCHITECTURAL PLANS, STRUCTURAL PLANS, AND OTHER RELATED DRAWINGS. THESE DRAWINGS REPRESENT ASI'S UNDERSTANDING AND INTERPRETATION OF THE ARCHITECTURAL DRAWINGS AND HOW ASI PRODUCTS RELATE TO THE PROJECT. COPYRIGHT ASI © 2022

$\frac{15}{16}$ " HD T-GRID MAINS
(BY OTHER)

INDEPENDENTLY SUPPORTED
CUSTOMER FIXTURE (FIELD
CUT PENETRATION)

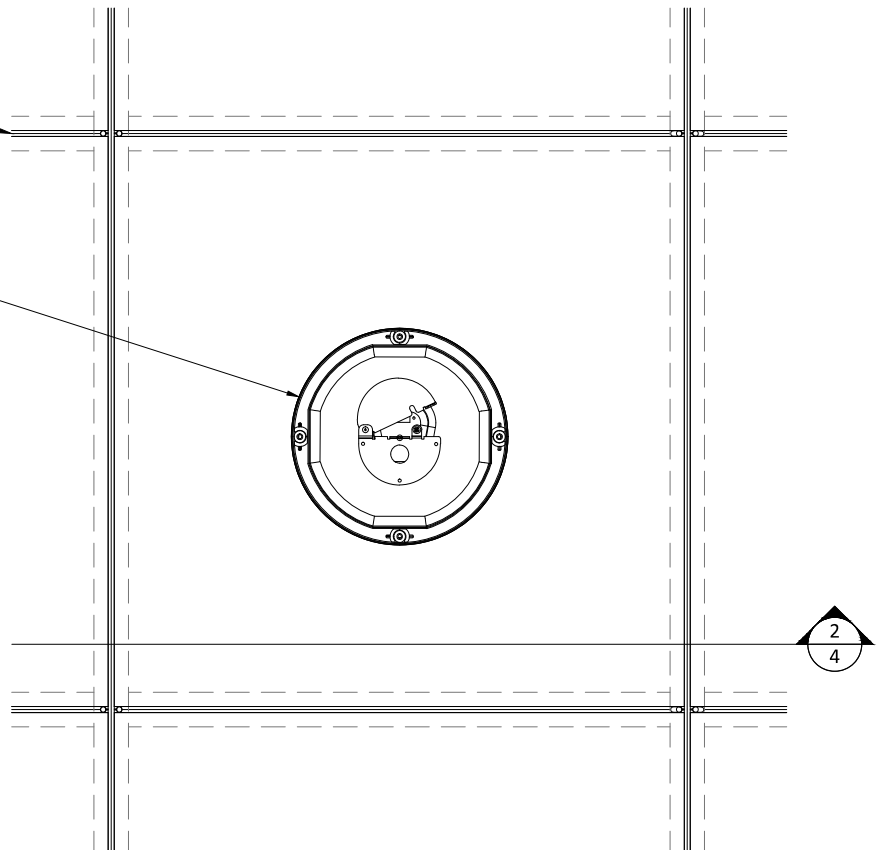


1 LAY-IN CEILING CAN LIGHT PLAN
4 SCALE: $1 \frac{1}{2}$ " = 1'-0"

SUSPENSION
(BY OTHER)

INDEPENDENTLY
SUPPORTED CUSTOMER
FIXTURE (BY OTHER)

FIELD CUT
PENETRATION

TRIM RING
(BY OTHER)

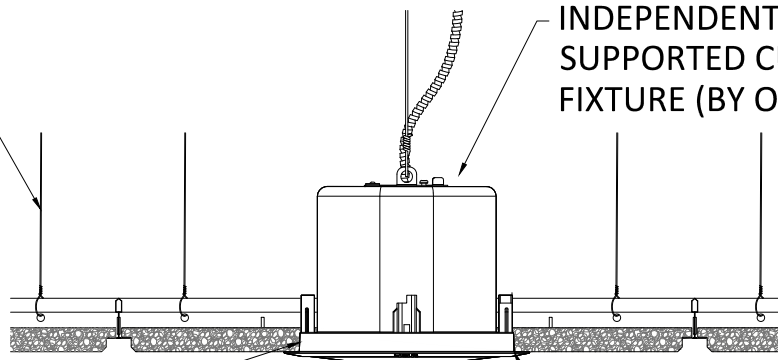

2 LAY-IN CEILING CAN LIGHT SECTION
4 SCALE: $1 \frac{1}{2}$ " = 1'-0"



123 Columbia Court North, Chaska,
Minnesota 55318 P. 800.527.6253

STRANDTEC- LAY-IN CEILING CAN LIGHT DETAILS

SCALE: AS NOTED

LAST REVISED: 7/6/2022

DRAWN BY: BH


SHEET NUMBER

4

DO NOT SCALE DRAWING. FIGURED DIMENSIONS ARE TO BE FOLLOWED. READ THIS DRAWING IN CONNECTION WITH GENERAL ARCHITECTURAL PLANS, STRUCTURAL PLANS, AND OTHER RELATED DRAWINGS. THESE DRAWINGS REPRESENT ASI'S UNDERSTANDING AND INTERPRETATION OF THE ARCHITECTURAL DRAWINGS AND HOW ASI PRODUCTS RELATE TO THE PROJECT. COPYRIGHT ASI © 2022

$\frac{15}{16}$ " HD T-GRID MAINS
(BY OTHER)

INDEPENDENTLY SUPPORTED
CUSTOMER FIXTURE (FIELD
CUT PENETRATION)

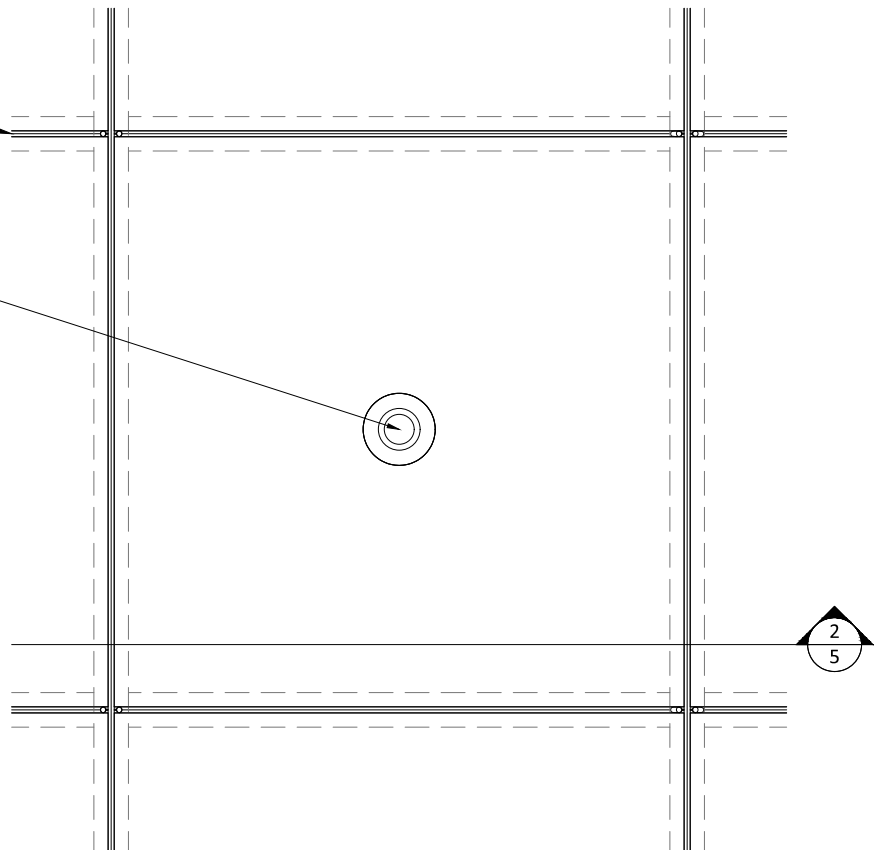


1
5 LAY-IN CEILING SPRINKLER PLAN
SCALE: 1 1/2" = 1'-0"

SUSPENSION
(BY OTHER)

INDEPENDENTLY
SUPPORTED CUSTOMER
FIXTURE (BY OTHER)

FIELD CUT
PENETRATION

TRIM RING
(BY OTHER)

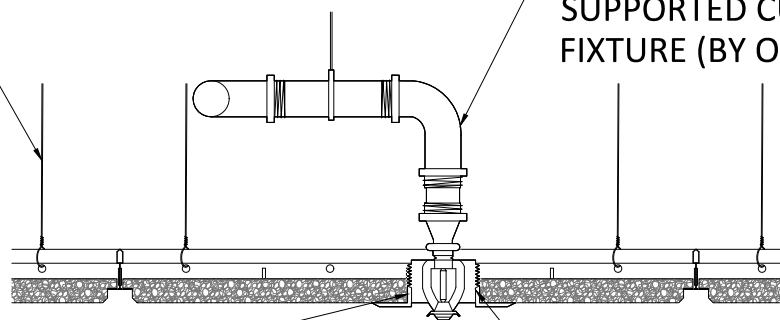

2
5 LAY-IN CEILING SPRINKLER SECTION
SCALE: 1 1/2" = 1'-0"

STRANDTEC- LAY-IN CEILING SPRINKLER DETAILS

SCALE: AS NOTED

LAST REVISED: 7/6/2022

DRAWN BY: BH

SHEET NUMBER

5


ASi

123 Columbia Court North, Chaska,
Minnesota 55318 P. 800.527.6253


DO NOT SCALE DRAWING. FIGURED DIMENSIONS ARE TO BE FOLLOWED. READ THIS DRAWING IN CONNECTION WITH GENERAL ARCHITECTURAL PLANS, STRUCTURAL PLANS, AND OTHER RELATED DRAWINGS. THESE DRAWINGS REPRESENT ASI'S UNDERSTANDING AND INTERPRETATION OF THE ARCHITECTURAL DRAWINGS AND HOW ASI PRODUCTS RELATE TO THE PROJECT. COPYRIGHT ASI © 2022

$\frac{15}{16}$ " HD T-GRID MAINS
(BY OTHER)

INDEPENDENTLY SUPPORTED
CUSTOMER FIXTURE (FIELD
CUT PENETRATION)

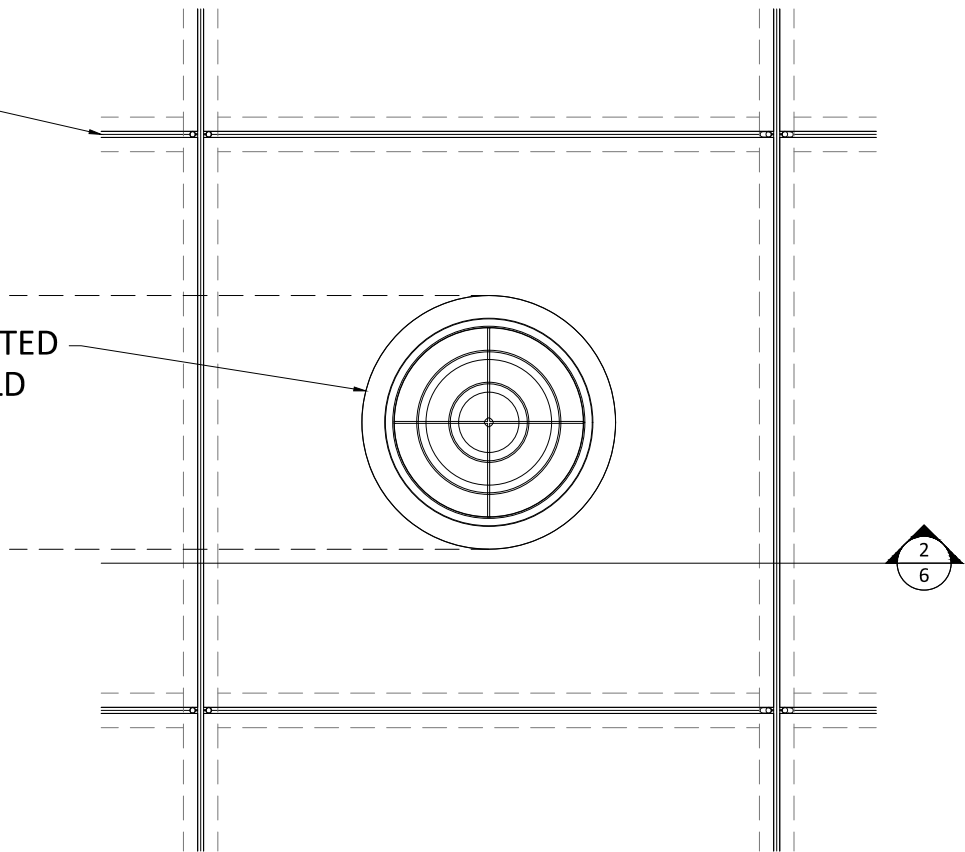

1 LAY-IN CEILING DIFFUSER PLAN
SCALE: $1\frac{1}{2}$ " = 1'-0"

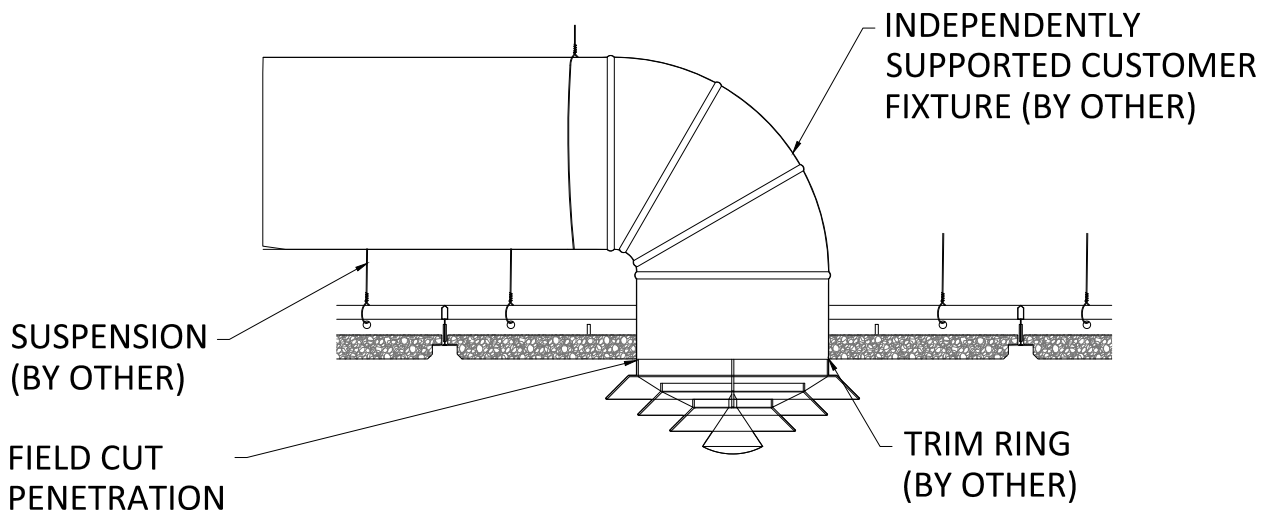

2 LAY-IN CEILING DIFFUSER SECTION
SCALE: $1\frac{1}{2}$ " = 1'-0"



123 Columbia Court North, Chaska,
Minnesota 55318 P. 800.527.6253

STRANDTEC- LAY-IN CEILING DIFFUSER DETAILS

SCALE: AS NOTED

LAST REVISED: 7/6/2022

DRAWN BY: BH


SHEET NUMBER

6

DO NOT SCALE DRAWING. FIGURED DIMENSIONS ARE TO BE FOLLOWED. READ THIS DRAWING IN CONNECTION WITH GENERAL ARCHITECTURAL PLANS, STRUCTURAL PLANS, AND OTHER RELATED DRAWINGS. THESE DRAWINGS REPRESENT ASI'S UNDERSTANDING AND INTERPRETATION OF THE ARCHITECTURAL DRAWINGS AND HOW ASI PRODUCTS RELATE TO THE PROJECT. COPYRIGHT ASI © 2022

$\frac{15}{16}$ " HD T-GRID MAINS
(BY OTHER)

INDEPENDENTLY SUPPORTED
CUSTOMER FIXTURE (FIELD
CUT PENETRATION)

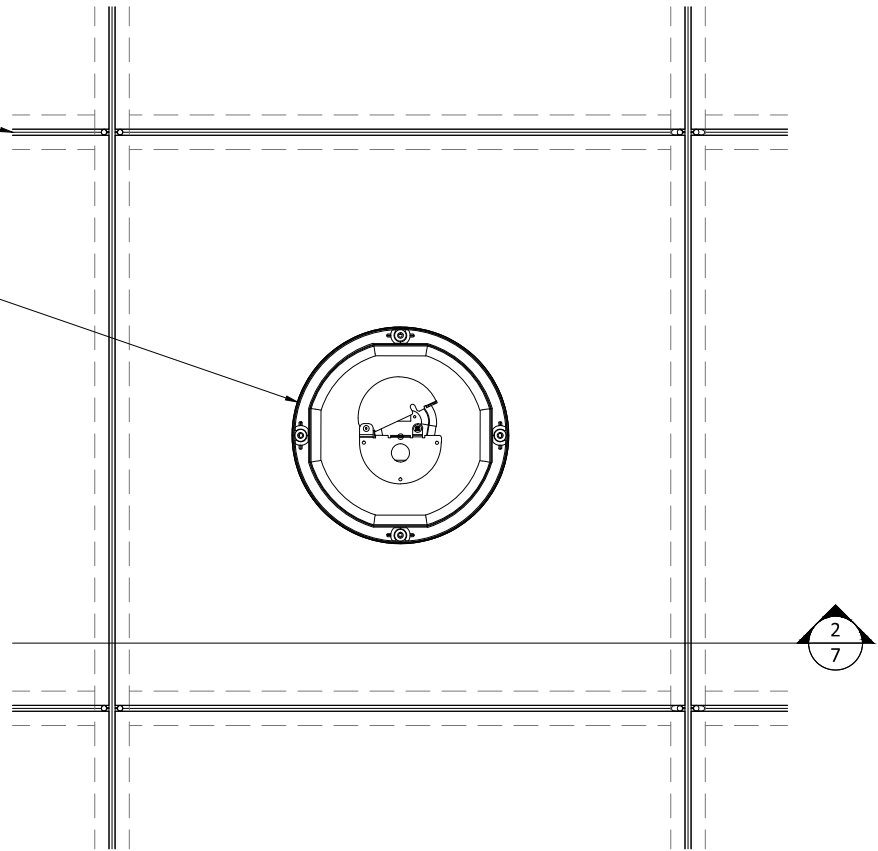


1 LAY-IN CEILING SPEAKER PLAN
SCALE: $1 \frac{1}{2}$ " = 1'-0"

SUSPENSION
(BY OTHER)

INDEPENDENTLY
SUPPORTED CUSTOMER
FIXTURE (BY OTHER)

FIELD CUT
PENETRATION

TRIM RING
(BY OTHER)

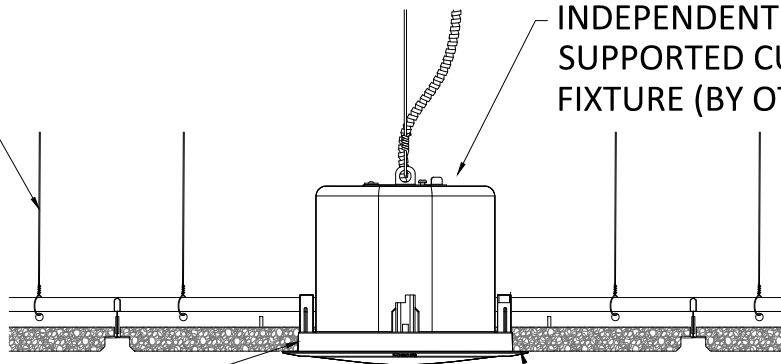

2 LAY-IN CEILING SPEAKER SECTION
SCALE: $1 \frac{1}{2}$ " = 1'-0"



123 Columbia Court North, Chaska,
Minnesota 55318 P. 800.527.6253

STRANDTEC- LAY-IN CEILING RECESSED SPEAKER DETAILS

SCALE: AS NOTED

LAST REVISED: 7/6/2022

DRAWN BY: BH


SHEET NUMBER

7

DO NOT SCALE DRAWING. FIGURED DIMENSIONS ARE TO BE FOLLOWED. READ THIS DRAWING IN CONNECTION WITH GENERAL ARCHITECTURAL PLANS, STRUCTURAL PLANS, AND OTHER RELATED DRAWINGS. THESE DRAWINGS REPRESENT ASI'S UNDERSTANDING AND INTERPRETATION OF THE ARCHITECTURAL DRAWINGS AND HOW ASI PRODUCTS RELATE TO THE PROJECT. COPYRIGHT ASI © 2022

15"
16" HD T-GRID MAINS
(BY OTHER)

INDEPENDENTLY SUPPORTED
CUSTOMER FIXTURE (FIELD
CUT PENETRATION)

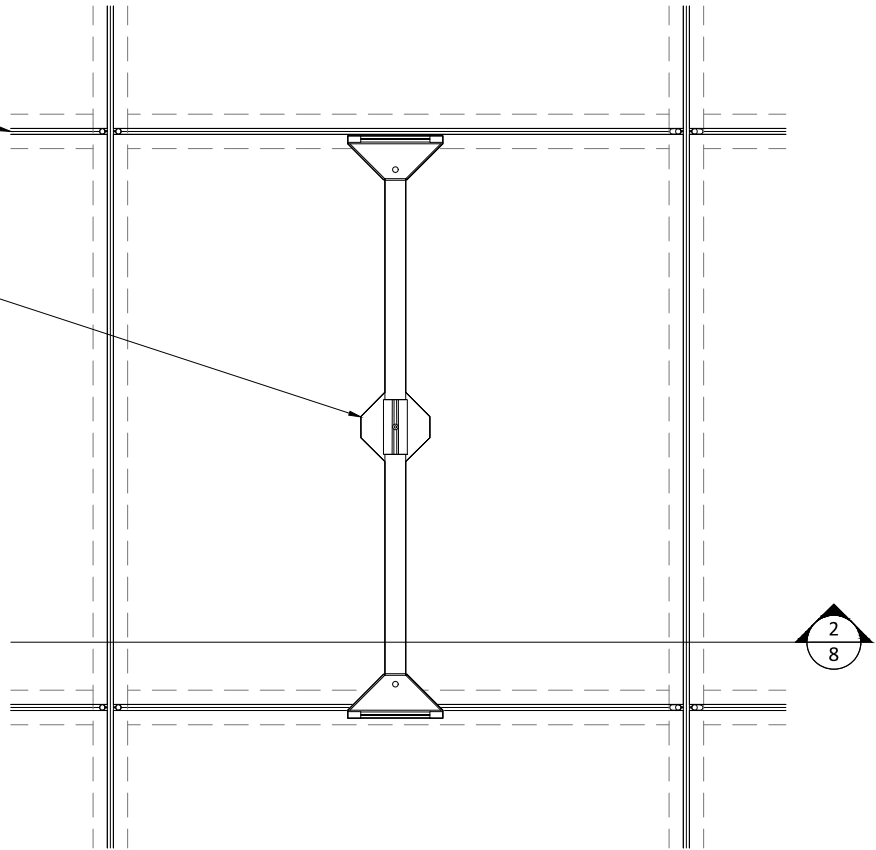


1 LAY-IN CEILING PENDANT LIGHT PLAN
8 SCALE: 1 1/2" = 1'-0"

SUSPENSION
(BY OTHER)

INDEPENDENTLY
SUPPORTED CUSTOMER
FIXTURE (BY OTHER)

FIELD CUT
PENETRATION

TRIM RING
(BY OTHER)

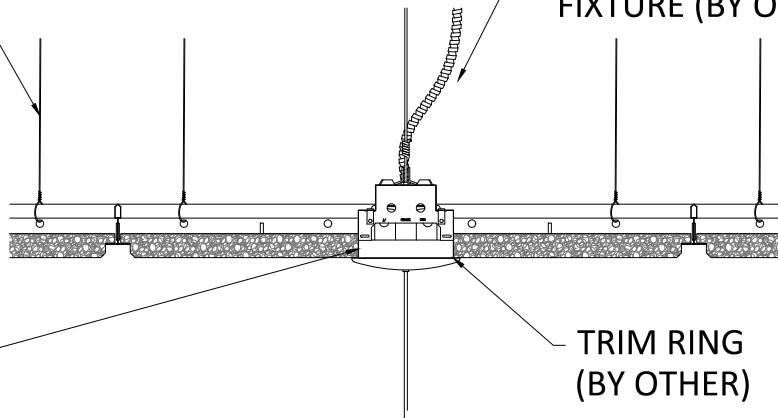

2 LAY-IN CEILING PENDANT LIGHT SECTION
8 SCALE: 1 1/2" = 1'-0"



123 Columbia Court North, Chaska,
Minnesota 55318 P. 800.527.6253

STRANDTEC- LAY-IN CEILING PENDANT LIGHT DETAILS

SCALE: AS NOTED

LAST REVISED: 7/6/2022

DRAWN BY: BH

SHEET NUMBER

8

DO NOT SCALE DRAWING. FIGURED DIMENSIONS ARE TO BE FOLLOWED. READ THIS DRAWING IN CONNECTION WITH GENERAL ARCHITECTURAL PLANS, STRUCTURAL PLANS, AND OTHER RELATED DRAWINGS. THESE DRAWINGS REPRESENT ASI'S UNDERSTANDING AND INTERPRETATION OF THE ARCHITECTURAL DRAWINGS AND HOW ASI PRODUCTS RELATE TO THE PROJECT. COPYRIGHT ASI © 2022